

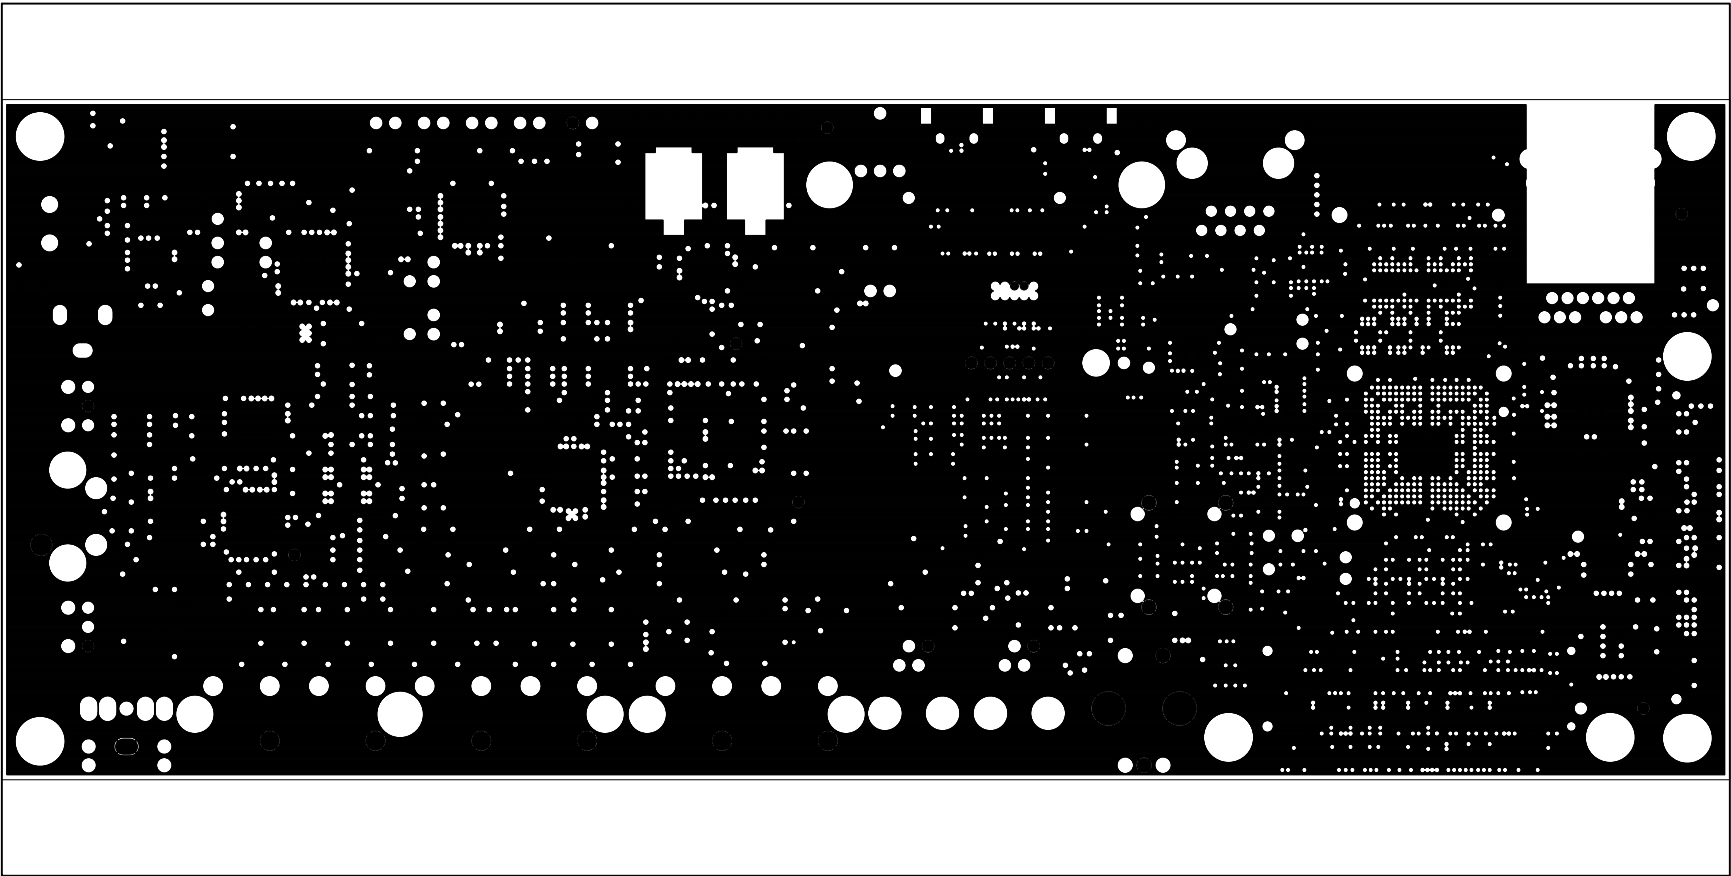


REVISIONS				
REV	DESCRIPTION OF CHANGE	DRFTR	DATE	APPROVED
0.1	NEW RELEASE	C.C.D.	10/19/15	
0.2	UPDATED PER ECO2016-003	C.C.D.	02/02/16	
1.0	UPDATED PER ECO2016-016	C.C.D.	05/10/16	
1.1	UPDATED PER ECO2017-011	C.C.D.	03/02/17	
1.2	UPDATED PER ECO2017-0xx	C.C.D.	04/18/17	
1.2	UPDATED PER ECO2017-018	C.C.D.	10/13/17	
1.3	UPDATED PER ECO2018-006	C.C.D.	05/15/18	

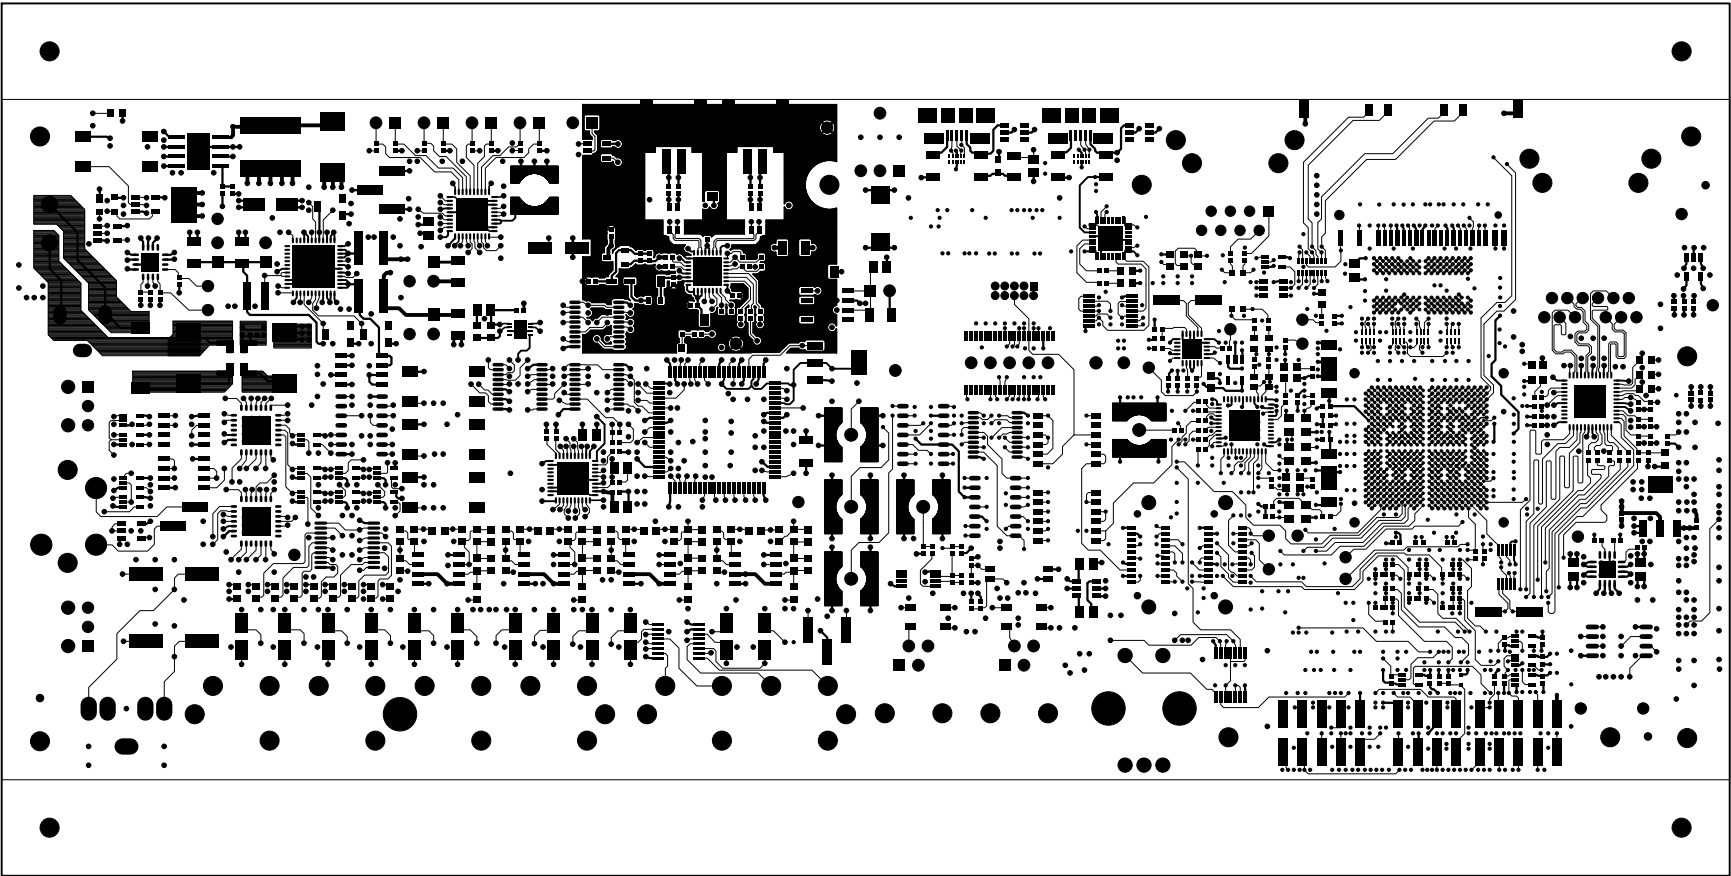


UNLESS OTHERWISE SPECIFIED DIMENSIONS ARE IN INCHES TOLERANCES ARE : .XX +/- .010 .XXX +/- .005	CONTRACT NO.		<div> 2 Elizabeth Drive Chelmsford, MA 01824</div>	
	APPROVALS	DATE		
MATERIAL	DRAWN	C.C.D.	05/15/18	LAYER 1 TOP SIDE ADSP-SC573 EZ-KIT
	CHECKED			
FINISH	ENGINEERING			SIZE B
	QUALITY			
DO NOT SCALE THIS DRAWING	MANUFACTURING			SCALE 1 : 1
			DWG. NO. A0760-2015	REV. 1.3
			SHEET 1 OF 16	


REVISIONS				
REV	DESCRIPTION OF CHANGE	DRFTR	DATE	APPROVED
0.1	NEW RELEASE	C.C.D.	10/19/15	
0.2	UPDATED PER EC02016-003	C.C.D.	02/02/16	
1.0	UPDATED PER EC02016-016	C.C.D.	05/10/16	
1.1	UPDATED PER EC02017-011	C.C.D.	03/02/17	
1.2	UPDATED PER EC02017-0xx	C.C.D.	04/18/17	
1.2	UPDATED PER EC02017-018	C.C.D.	10/13/17	
1.3	UPDATED PER EC02018-006	C.C.D.	05/15/18	




UNLESS OTHERWISE SPECIFIED DIMENSIONS ARE IN INCHES TOLERANCES ARE : .XX +/- .010 .XXX +/- .005	CONTRACT NO.		<div><div><div></div><div>ANALOG DEVICES</div></div><div>2 Elizabeth Drive Chelmsford, MA 01824</div></div>		
	APPROVALS	DATE			
	MATERIAL	DRAWN C.C.D.	05/15/18	LAYER 2 GROUND PLANE ADSP-SC573 EZ-KIT	
FINISH	CHECKED				
	ENGINEERING				
	QUALITY				
DO NOT SCALE THIS DRAWING	MANUFACTURING		SIZE B	DWG. NO. A0760-2015	REV. 1.3
			SCALE 1 : 1	SHEET 2 OF 16	

REVISIONS				
REV	DESCRIPTION OF CHANGE	DRFTR	DATE	APPROVED
0.1	NEW RELEASE	C.C.D.	10/19/15	
0.2	UPDATED PER ECO2016-003	C.C.D.	02/02/16	
1.0	UPDATED PER ECO2016-016	C.C.D.	05/10/16	
1.1	UPDATED PER ECO2017-011	C.C.D.	03/02/17	
1.2	UPDATED PER ECO2017-0xx	C.C.D.	04/18/17	
1.2	UPDATED PER ECO2017-018	C.C.D.	10/13/17	
1.3	UPDATED PER ECO2018-006	C.C.D.	05/15/18	

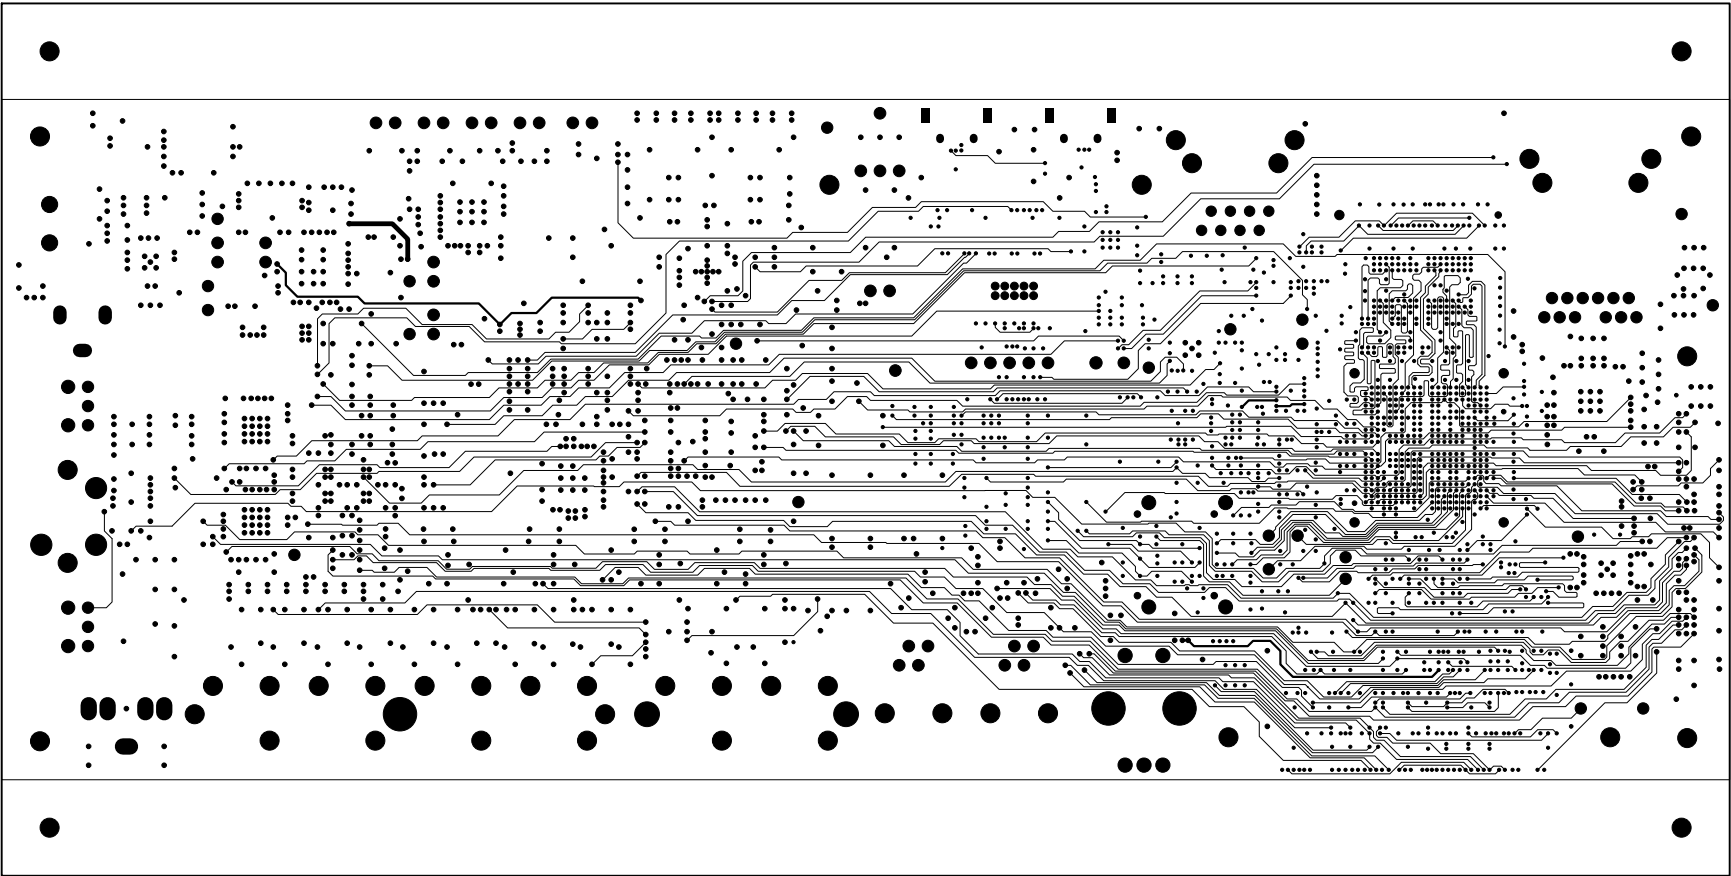


UNLESS OTHERWISE SPECIFIED DIMENSIONS ARE IN INCHES TOLERANCES ARE : .XX +/- .010 .XXX +/- .005	CONTRACT NO.		 2 Elizabeth Drive Chelmsford, MA 01824	
	APPROVALS	DATE		
	DRAWN C.C.D.	05/15/18	LAYER 3 INTERNAL SIGNAL ADSP-SC573 EZ-KIT	
	CHECKED			
MATERIAL	ENGINEERING		SIZE B	DWG. NO. A0760-2015
FINISH	QUALITY			
DO NOT SCALE THIS DRAWING	MANUFACTURING		SCALE 1 : 1	SHEET 3 OF 16

REVISIONS				
REV	DESCRIPTION OF CHANGE	DRFTR	DATE	APPROVED
0.1	NEW RELEASE	C.C.D.	10/19/15	
0.2	UPDATED PER EC02016-003	C.C.D.	02/02/16	
1.0	UPDATED PER EC02016-016	C.C.D.	05/10/16	
1.1	UPDATED PER EC02017-011	C.C.D.	03/02/17	
1.2	UPDATED PER EC02017-0xx	C.C.D.	04/18/17	
1.2	UPDATED PER EC02017-018	C.C.D.	10/13/17	
1.3	UPDATED PER EC02018-006	C.C.D.	05/15/18	

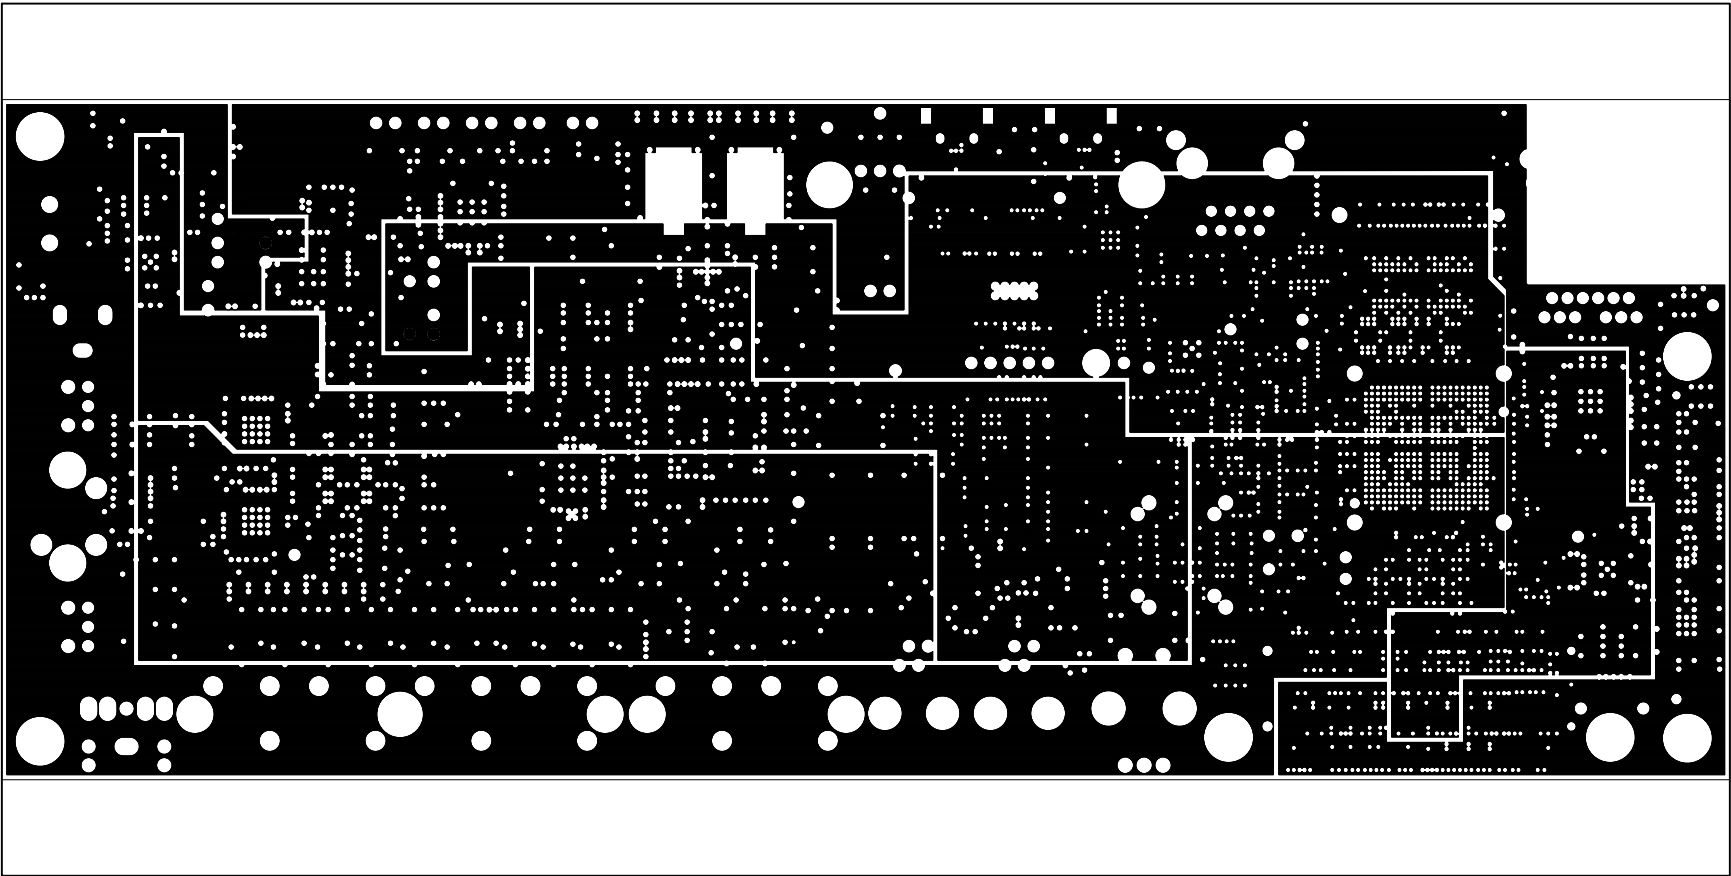


UNLESS OTHERWISE SPECIFIED DIMENSIONS ARE IN INCHES TOLERANCES ARE : .XX +/- .010 .XXX +/- .005	CONTRACT NO.		<div><div></div><div>ANALOG DEVICES</div></div> <div>2 Elizabeth Drive Chelmsford, MA 01824</div>
	APPROVALS	DATE	
	DRAWN C.C.D.	05/15/18	LAYER 4 POWER PLANE ADSP-SC573 EZ-KIT
	CHECKED		
MATERIAL	ENGINEERING		SIZE B
FINISH	QUALITY		
DO NOT SCALE THIS DRAWING	MANUFACTURING		SCALE 1 : 1
		DWG. NO.	REV.
		A0760-2015	1.3
		SHEET 4 OF 16	


REVISIONS				
REV	DESCRIPTION OF CHANGE	DRFTR	DATE	APPROVED
0.1	NEW RELEASE	C.C.D.	10/19/15	
0.2	UPDATED PER EC02016-003	C.C.D.	02/02/16	
1.0	UPDATED PER EC02016-016	C.C.D.	05/10/16	
1.1	UPDATED PER EC02017-011	C.C.D.	03/02/17	
1.2	UPDATED PER EC02017-0xx	C.C.D.	04/18/17	
1.2	UPDATED PER EC02017-018	C.C.D.	10/13/17	
1.3	UPDATED PER EC02018-006	C.C.D.	05/15/18	

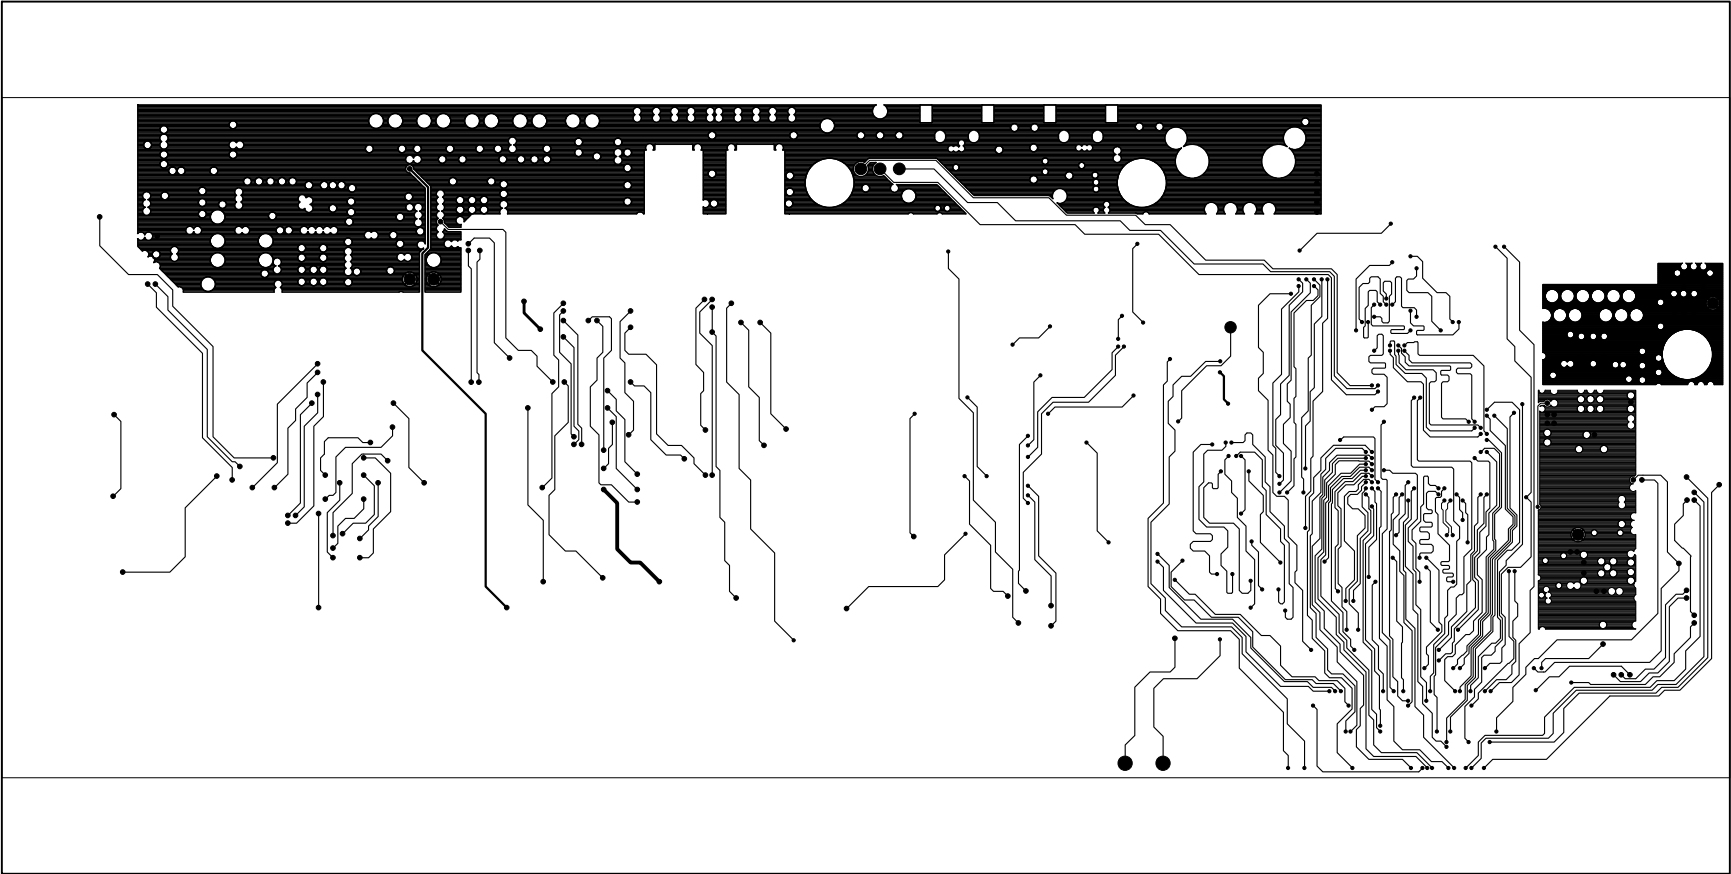


UNLESS OTHERWISE SPECIFIED DIMENSIONS ARE IN INCHES TOLERANCES ARE : .XX +/- .010 .XXX +/- .005	CONTRACT NO.		<div><div><div></div></div><div>ANALOG DEVICES</div></div> <div>2 Elizabeth Drive Chelmsford, MA 01824</div>		
	APPROVALS	DATE			
	DRAWN	C.C.D.	05/15/18	LAYER 5 INTERNAL SIGNAL ADSP-SC573 EZ-KIT	
	CHECKED				
MATERIAL	ENGINEERING			SIZE B	DWG. NO. A0760-2015
FINISH	QUALITY				
DO NOT SCALE THIS DRAWING	MANUFACTURING			SCALE 1 : 1	SHEET 5 OF 16

REVISIONS				
REV	DESCRIPTION OF CHANGE	DRFTR	DATE	APPROVED
0.1	NEW RELEASE	C.C.D.	10/19/15	
0.2	UPDATED PER ECO2016-003	C.C.D.	02/02/16	
1.0	UPDATED PER ECO2016-016	C.C.D.	05/10/16	
1.1	UPDATED PER ECO2017-011	C.C.D.	03/02/17	
1.2	UPDATED PER ECO2017-0xx	C.C.D.	04/18/17	
1.2	UPDATED PER ECO2017-018	C.C.D.	10/13/17	
1.3	UPDATED PER ECO2018-006	C.C.D.	05/15/18	

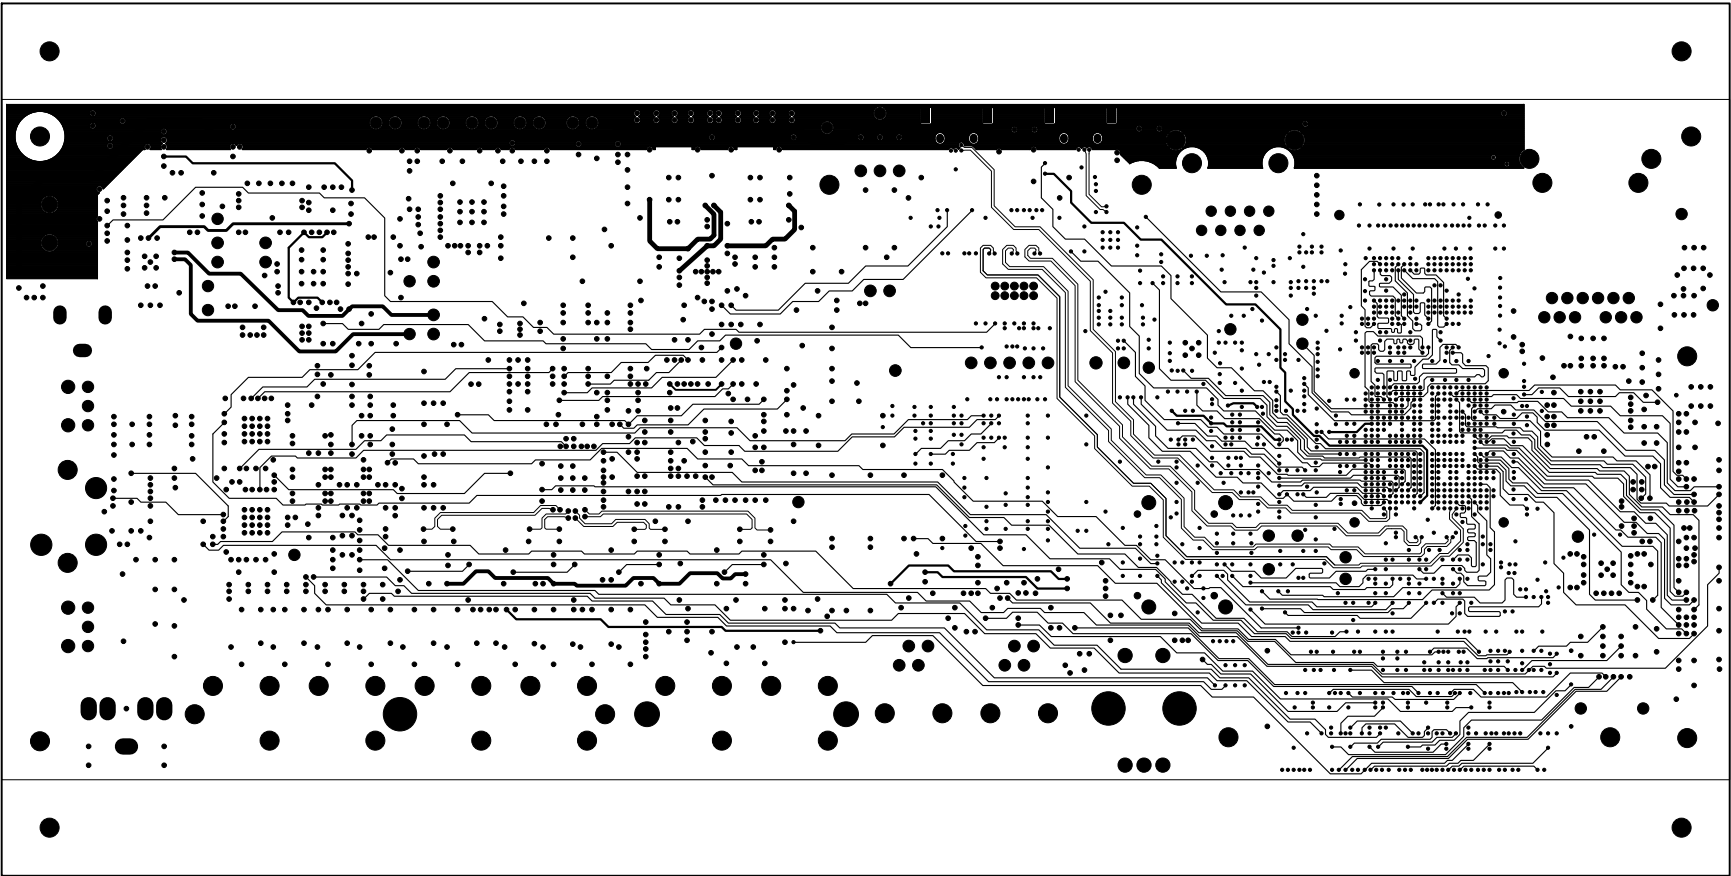


UNLESS OTHERWISE SPECIFIED DIMENSIONS ARE IN INCHES TOLERANCES ARE : .XX +/- .010 .XXX +/- .005	CONTRACT NO.		<div>2 Elizabeth Drive Chelmsford, MA 01824</div>	
	APPROVALS	DATE		
MATERIAL	DRAWN	C.C.D.	05/15/18	LAYER 6 INTERNAL SIGNAL ADSP-SC573 EZ-KIT
	CHECKED			
FINISH	ENGINEERING			SIZE B
	QUALITY			
DO NOT SCALE THIS DRAWING	MANUFACTURING			SCALE 1 : 1
			DWG. NO. A0760-2015	REV. 1.3
			SHEET 6 OF 16	


REVISIONS				
REV	DESCRIPTION OF CHANGE	DRFTR	DATE	APPROVED
0.1	NEW RELEASE	C.C.D.	10/19/15	
0.2	UPDATED PER ECO2016-003	C.C.D.	02/02/16	
1.0	UPDATED PER ECO2016-016	C.C.D.	05/10/16	
1.1	UPDATED PER ECO2017-011	C.C.D.	03/02/17	
1.2	UPDATED PER ECO2017-0xx	C.C.D.	04/18/17	
1.2	UPDATED PER ECO2017-018	C.C.D.	10/13/17	
1.3	UPDATED PER ECO2018-006	C.C.D.	05/15/18	

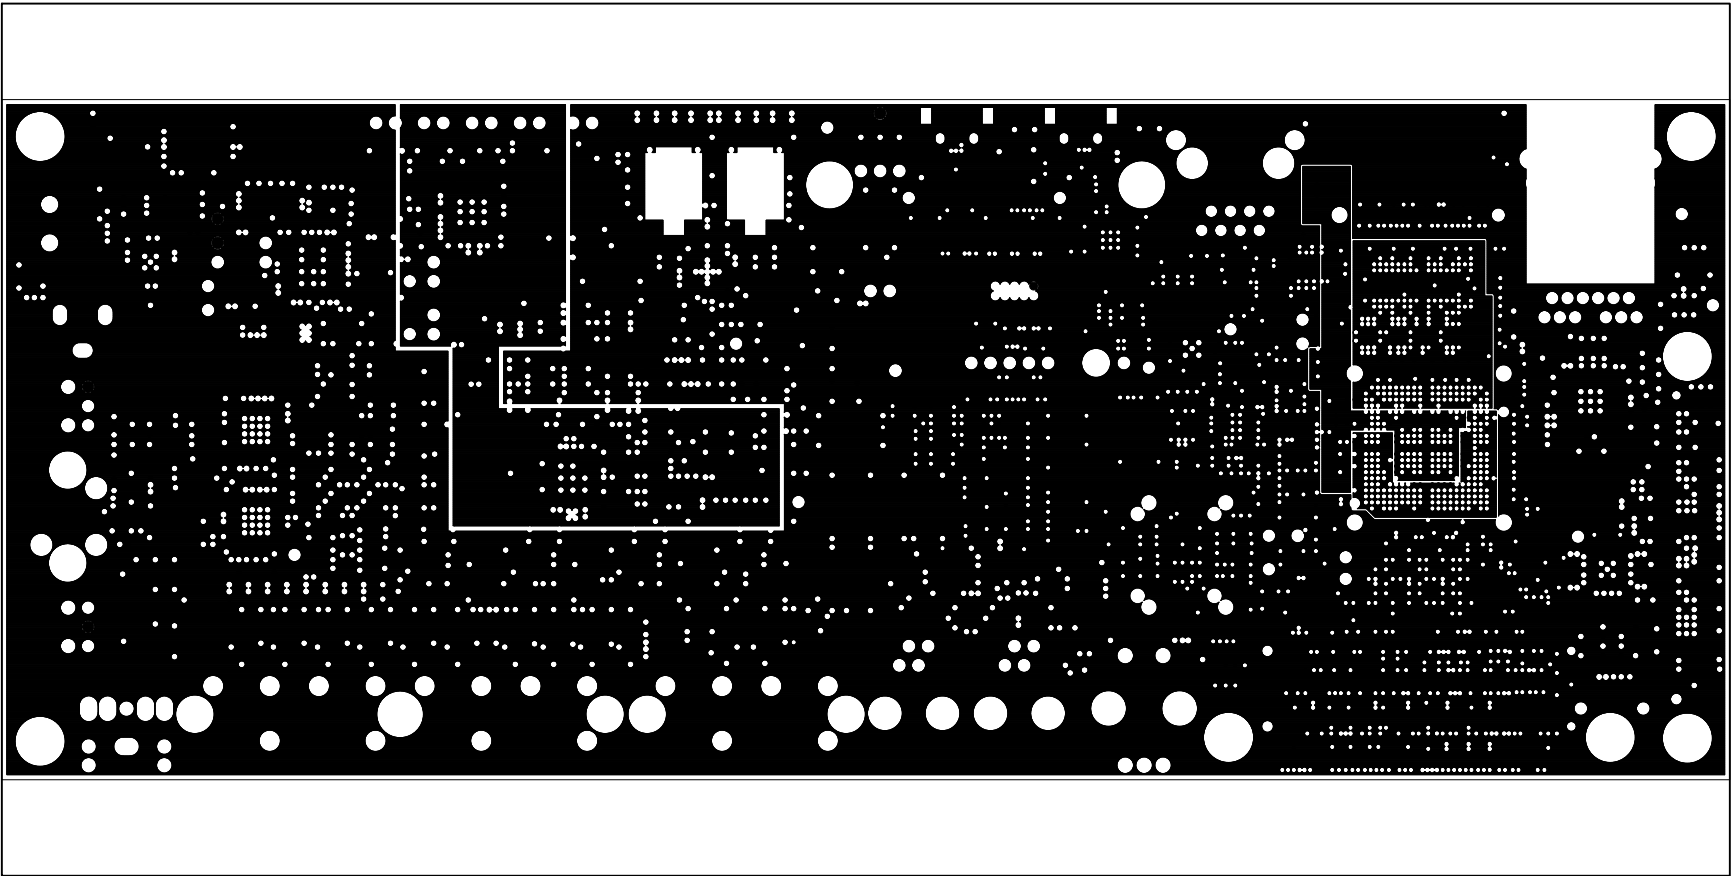


UNLESS OTHERWISE SPECIFIED DIMENSIONS ARE IN INCHES TOLERANCES ARE : .XX +/- .010 .XXX +/- .005	CONTRACT NO.		<div><div></div><div>ANALOG DEVICES</div></div> <div>2 Elizabeth Drive Chelmsford, MA 01824</div>		
	APPROVALS	DATE			
	DRAWN	C.C.D.	05/15/18	LAYER 7 POWER PLANE ADSP-SC573 EZ-KIT	
	CHECKED				
MATERIAL	ENGINEERING			SIZE B	DWG. NO. A0760-2015
FINISH	QUALITY				
DO NOT SCALE THIS DRAWING	MANUFACTURING			SCALE 1 : 1	SHEET 7 OF 16


REVISIONS				
REV	DESCRIPTION OF CHANGE	DRFTR	DATE	APPROVED
0.1	NEW RELEASE	C.C.D.	10/19/15	
0.2	UPDATED PER ECO2016-003	C.C.D.	02/02/16	
1.0	UPDATED PER ECO2016-016	C.C.D.	05/10/16	
1.1	UPDATED PER ECO2017-011	C.C.D.	03/02/17	
1.2	UPDATED PER ECO2017-0xx	C.C.D.	04/18/17	
1.2	UPDATED PER ECO2017-018	C.C.D.	10/13/17	
1.3	UPDATED PER ECO2018-006	C.C.D.	05/15/18	

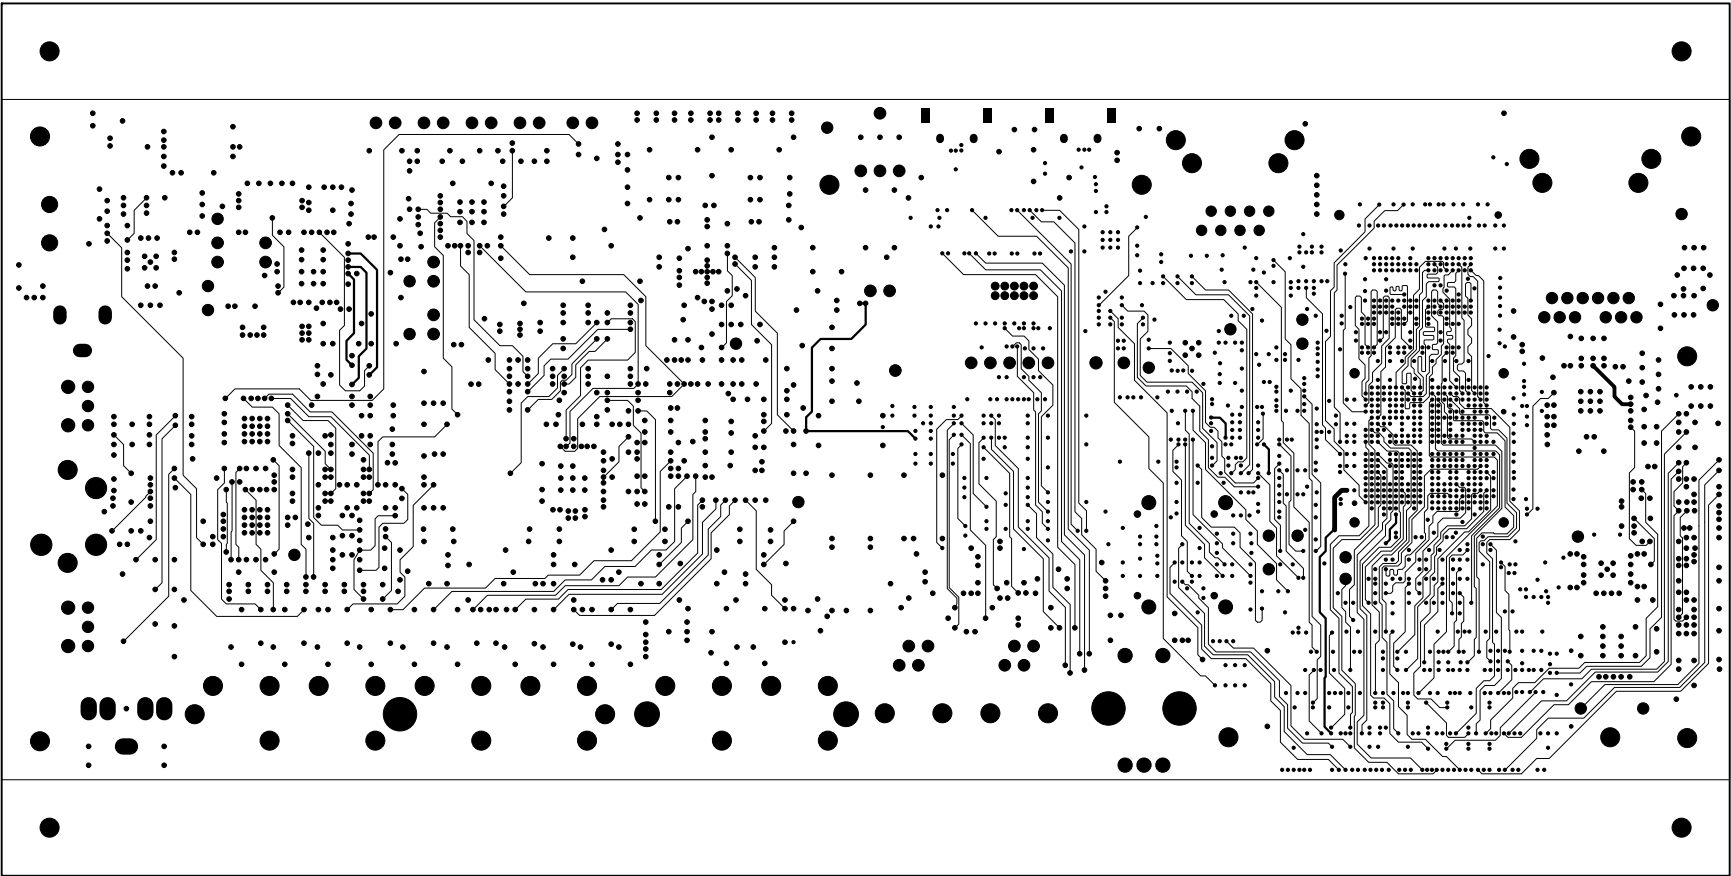


UNLESS OTHERWISE SPECIFIED DIMENSIONS ARE IN INCHES TOLERANCES ARE : .XX +/- .010 .XXX +/- .005	CONTRACT NO.		 2 Elizabeth Drive Chelmsford, MA 01824	
	APPROVALS	DATE		
	DRAWN	C.C.D.	05/15/18	LAYER 8 INTERNAL SIGNAL ADSP-SC573 EZ-KIT
	CHECKED			
FINISH	ENGINEERING		SIZE	DWG. NO. A0760-2015
	QUALITY		B	
DO NOT SCALE THIS DRAWING	MANUFACTURING		SCALE	1 : 1
			SHEET	8 OF 16


REVISIONS				
REV	DESCRIPTION OF CHANGE	DRFTR	DATE	APPROVED
0.1	NEW RELEASE	C.C.D.	10/19/15	
0.2	UPDATED PER ECO2016-003	C.C.D.	02/02/16	
1.0	UPDATED PER ECO2016-016	C.C.D.	05/10/16	
1.1	UPDATED PER ECO2017-011	C.C.D.	03/02/17	
1.2	UPDATED PER ECO2017-0xx	C.C.D.	04/18/17	
1.2	UPDATED PER ECO2017-018	C.C.D.	10/13/17	
1.3	UPDATED PER ECO2018-006	C.C.D.	05/15/18	

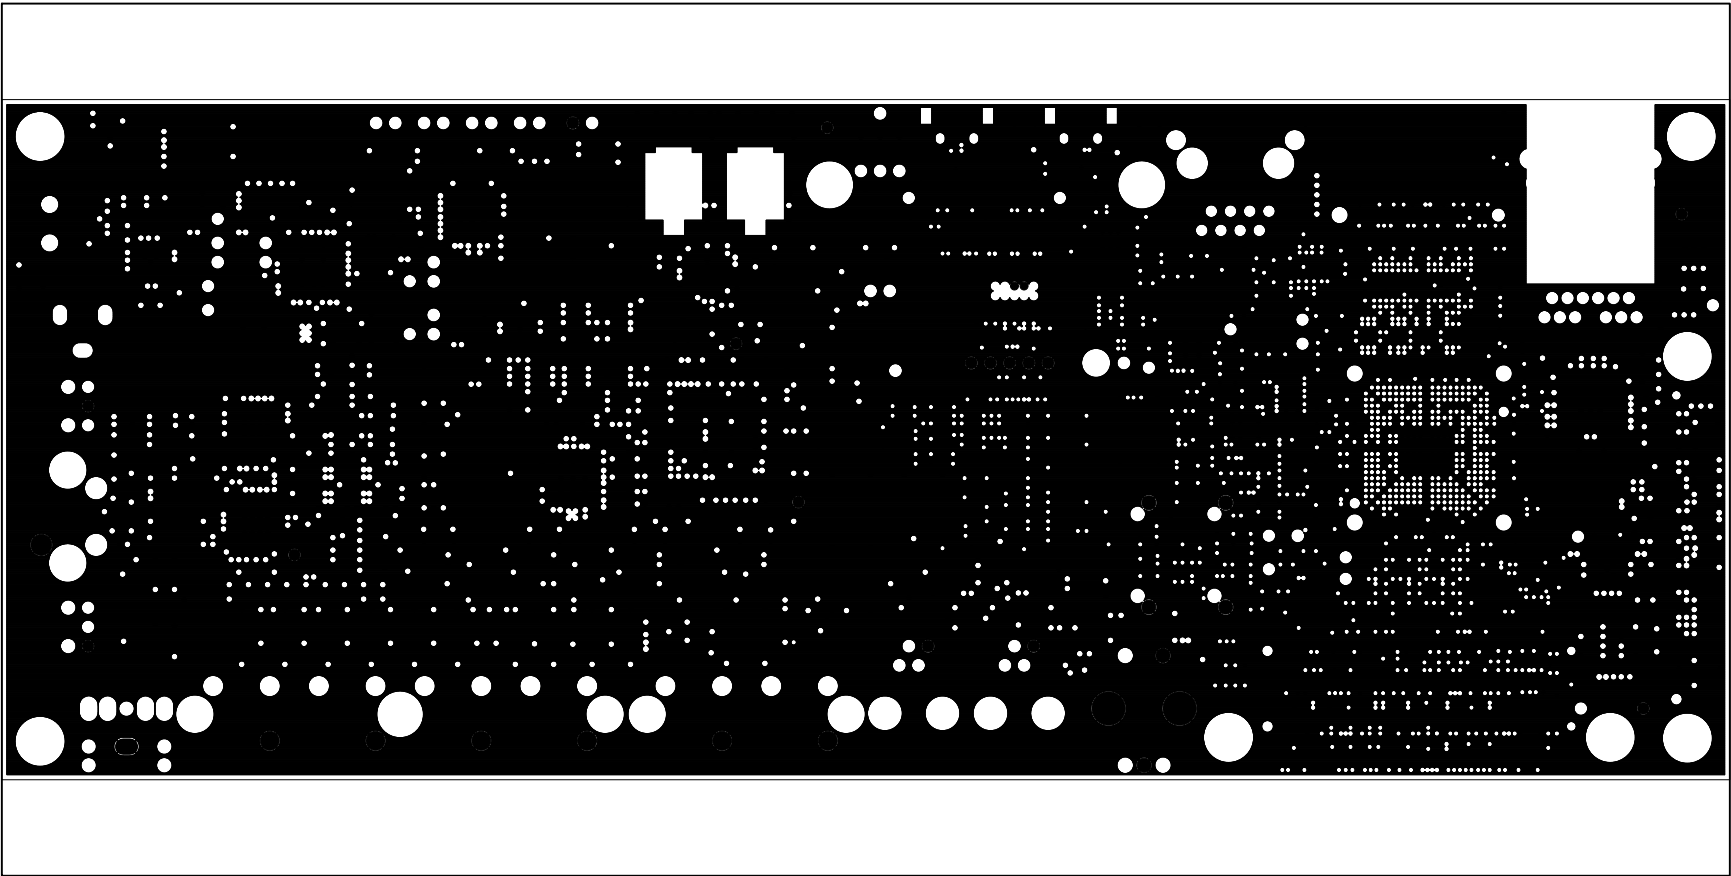


UNLESS OTHERWISE SPECIFIED DIMENSIONS ARE IN INCHES TOLERANCES ARE : .XX +/- .010 .XXX +/- .005	CONTRACT NO.		<div><div></div><div>2 Elizabeth Drive Chelmsford, MA 01824</div></div>		
	APPROVALS	DATE			
	DRAWN	C.C.D.	05/15/18	LAYER 9 GROUND PLANE ADSP-SC573 EZ-KIT	
	CHECKED				
MATERIAL	ENGINEERING		SIZE	DWG. NO.	REV.
FINISH	QUALITY		B		
DO NOT SCALE THIS DRAWING	MANUFACTURING		SCALE	1 : 1	SHEET 9 OF 16


REVISIONS				
REV	DESCRIPTION OF CHANGE	DRFTR	DATE	APPROVED
0.1	NEW RELEASE	C.C.D.	10/19/15	
0.2	UPDATED PER ECO2016-003	C.C.D.	02/02/16	
1.0	UPDATED PER ECO2016-016	C.C.D.	05/10/16	
1.1	UPDATED PER ECO2017-011	C.C.D.	03/02/17	
1.2	UPDATED PER ECO2017-0xx	C.C.D.	04/18/17	
1.2	UPDATED PER ECO2017-018	C.C.D.	10/13/17	
1.3	UPDATED PER ECO2018-006	C.C.D.	05/15/18	

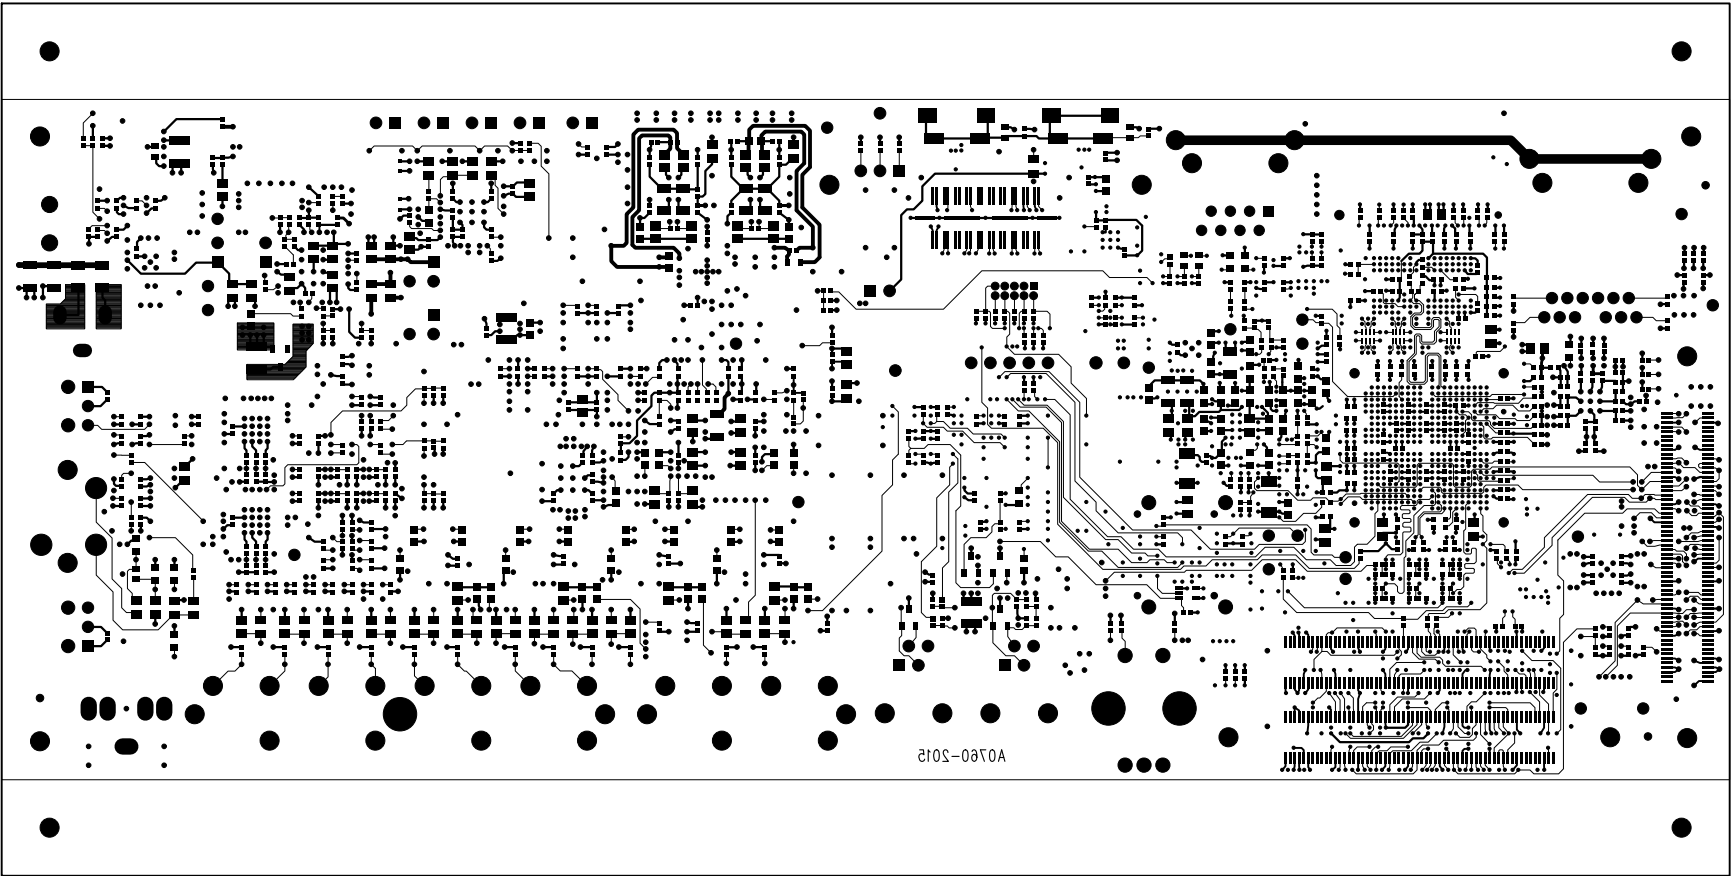


UNLESS OTHERWISE SPECIFIED DIMENSIONS ARE IN INCHES TOLERANCES ARE : .XX +/- .010 .XXX +/- .005	CONTRACT NO.		 2 Elizabeth Drive Chelmsford, MA 01824	
	APPROVALS	DATE		
	DRAWN	C.C.D.	05/15/18	LAYER 10 BOTTOM SIDE ADSP-SC573 EZ-KIT
	CHECKED			
MATERIAL	ENGINEERING		SIZE B	DWG. NO. A0760-2015
FINISH	QUALITY			
DO NOT SCALE THIS DRAWING	MANUFACTURING		SCALE 1 : 1	SHEET 10 OF 16


REVISIONS				
REV	DESCRIPTION OF CHANGE	DRFTR	DATE	APPROVED
0.1	NEW RELEASE	C.C.D.	10/19/15	
0.2	UPDATED PER ECO2016-003	C.C.D.	02/02/16	
1.0	UPDATED PER ECO2016-016	C.C.D.	05/10/16	
1.1	UPDATED PER ECO2017-011	C.C.D.	03/02/17	
1.2	UPDATED PER ECO2017-0xx	C.C.D.	04/18/17	
1.2	UPDATED PER ECO2017-018	C.C.D.	10/13/17	
1.3	UPDATED PER ECO2018-006	C.C.D.	05/15/18	

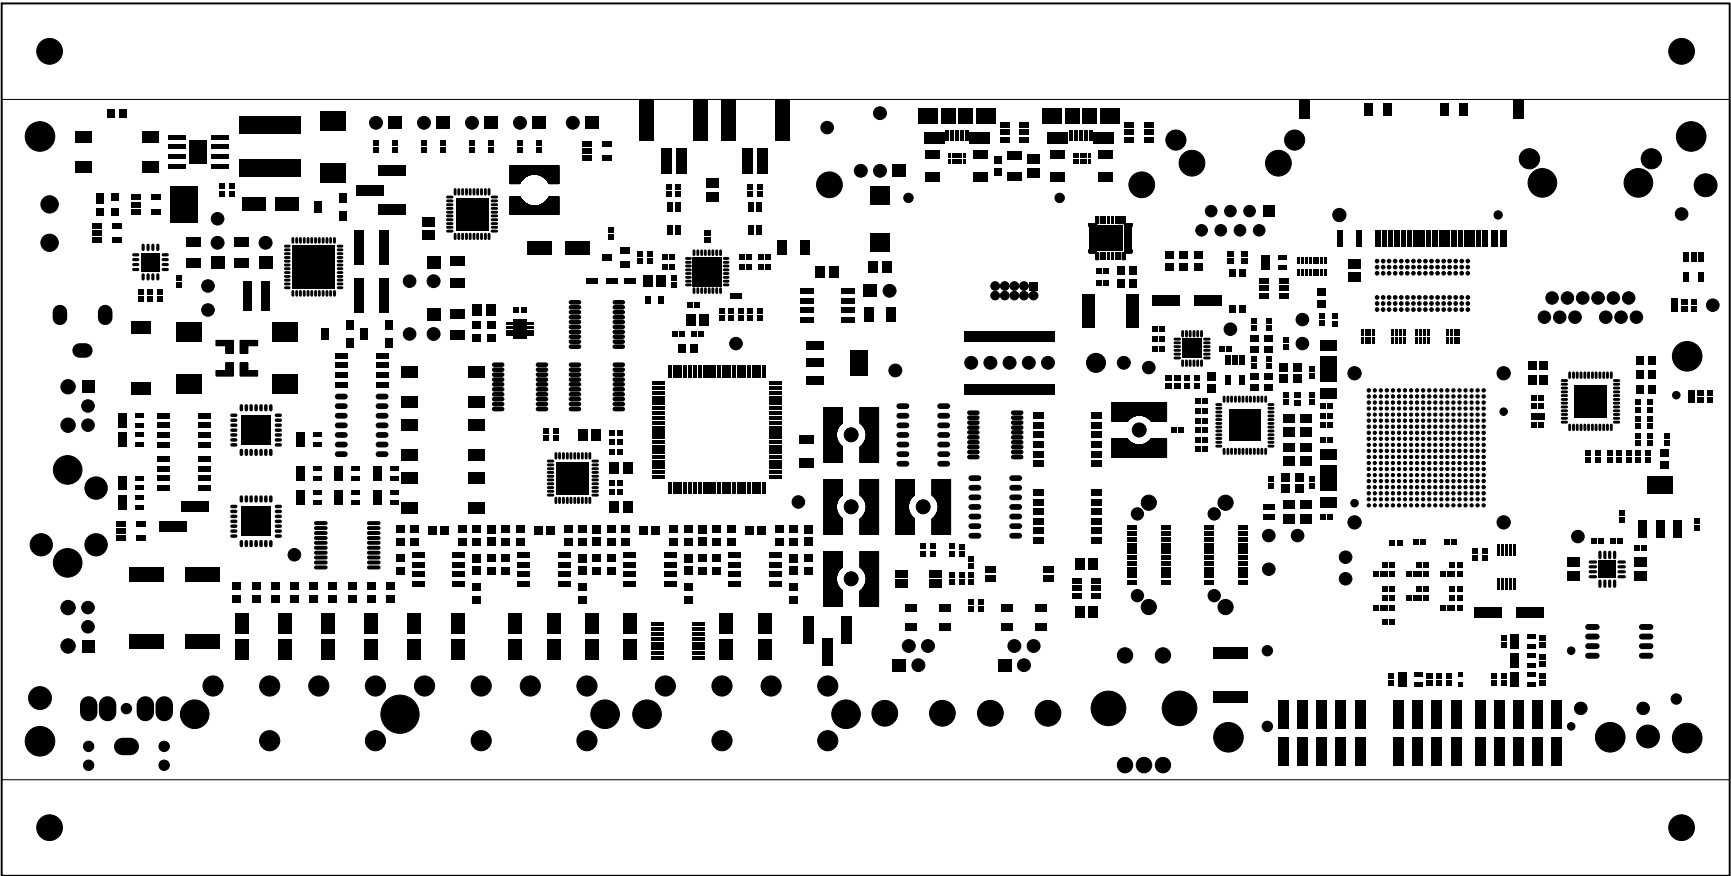


UNLESS OTHERWISE SPECIFIED DIMENSIONS ARE IN INCHES TOLERANCES ARE : .XX +/- .010 .XXX +/- .005	CONTRACT NO.		<div> 2 Elizabeth Drive Chelmsford, MA 01824</div>		
	APPROVALS	DATE			
	DRAWN C.C.D.	05/15/18	SOLDER MASK TOP SIDE ADSP-SC573 EZ-KIT		
MATERIAL	CHECKED				
FINISH	ENGINEERING		SIZE B	DWG. NO. A0760-2015	REV. 1.3
DO NOT SCALE THIS DRAWING	QUALITY		SCALE 1 : 1		
	MANUFACTURING			SHEET 11 OF 16	


REVISIONS				
REV	DESCRIPTION OF CHANGE	DRFTR	DATE	APPROVED
0.1	NEW RELEASE	C.C.D.	10/19/15	
0.2	UPDATED PER ECO2016-003	C.C.D.	02/02/16	
1.0	UPDATED PER ECO2016-016	C.C.D.	05/10/16	
1.1	UPDATED PER ECO2017-011	C.C.D.	03/02/17	
1.2	UPDATED PER ECO2017-0xx	C.C.D.	04/18/17	
1.2	UPDATED PER ECO2017-018	C.C.D.	10/13/17	
1.3	UPDATED PER ECO2018-006	C.C.D.	05/15/18	

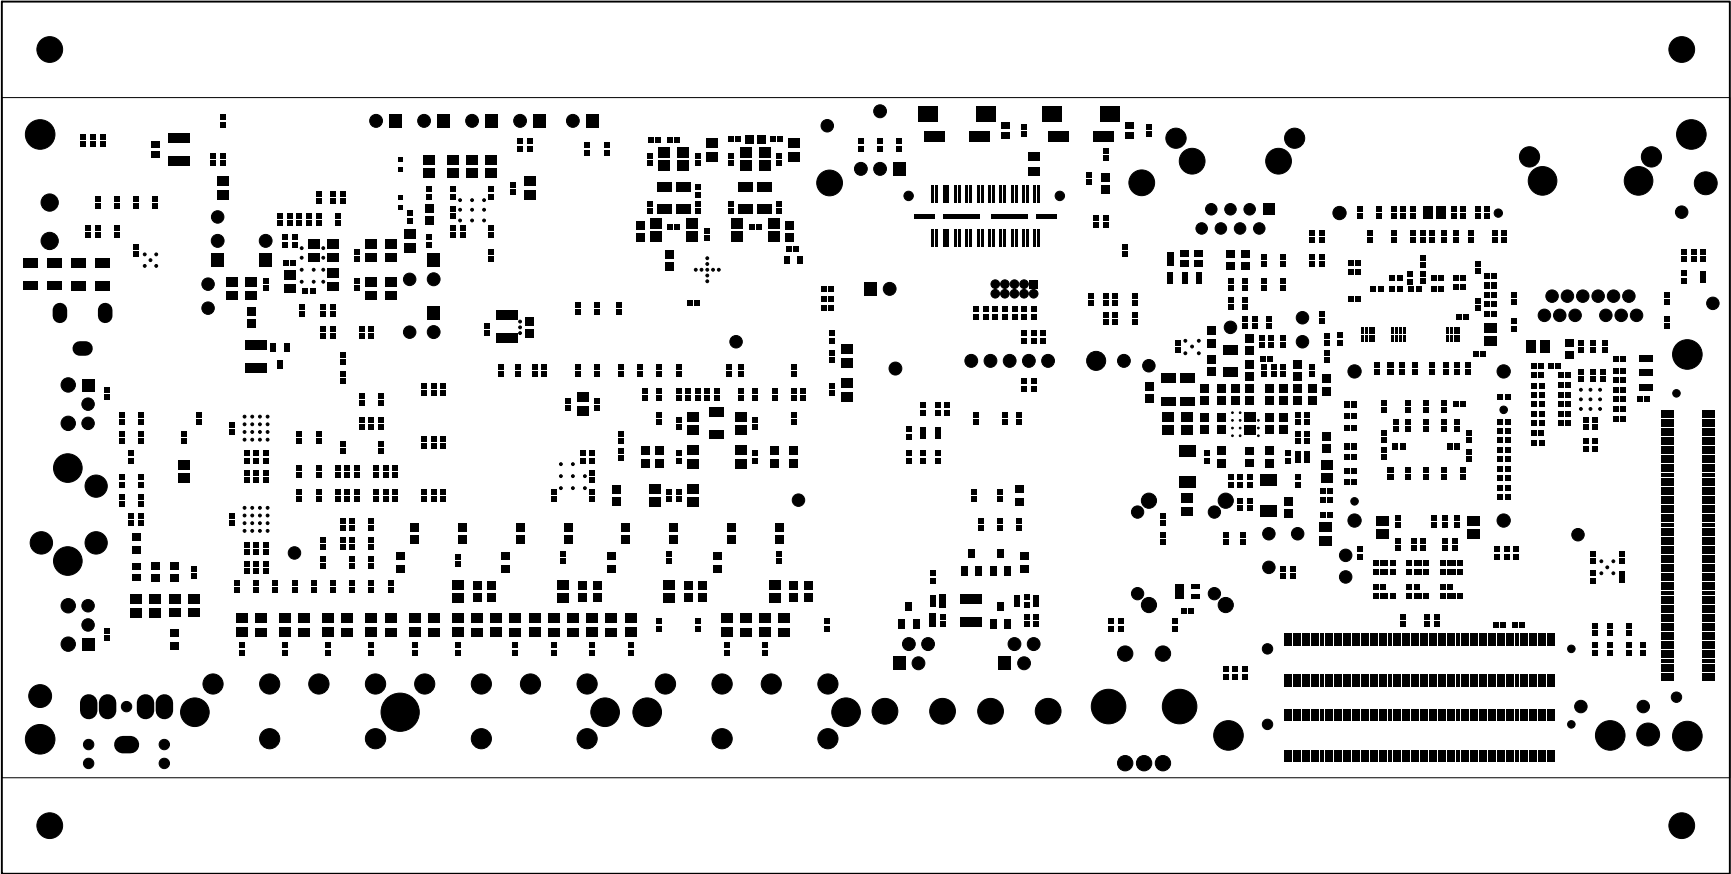


UNLESS OTHERWISE SPECIFIED DIMENSIONS ARE IN INCHES TOLERANCES ARE : .XX +/- .010 .XXX +/- .005	CONTRACT NO.		<div> 2 Elizabeth Drive Chelmsford, MA 01824</div>		
	APPROVALS	DATE			
	DRAWN C.C.D.	05/15/18	SOLDER MASK BOTTOM SIDE ADSP-SC573 EZ-KIT		
MATERIAL	CHECKED				
FINISH	ENGINEERING		SIZE B	DWG. NO. A0760-2015	REV. 1.3
DO NOT SCALE THIS DRAWING	QUALITY		SCALE 1 : 1		
	MANUFACTURING			SHEET 12 OF 16	


REVISIONS				
REV	DESCRIPTION OF CHANGE	DRFTR	DATE	APPROVED
0.1	NEW RELEASE	C.C.D.	10/19/15	
0.2	UPDATED PER ECO2016-003	C.C.D.	02/02/16	
1.0	UPDATED PER ECO2016-016	C.C.D.	05/10/16	
1.1	UPDATED PER ECO2017-011	C.C.D.	03/02/17	
1.2	UPDATED PER ECO2017-0xx	C.C.D.	04/18/17	
1.2	UPDATED PER ECO2017-018	C.C.D.	10/13/17	
1.3	UPDATED PER ECO2018-006	C.C.D.	05/15/18	

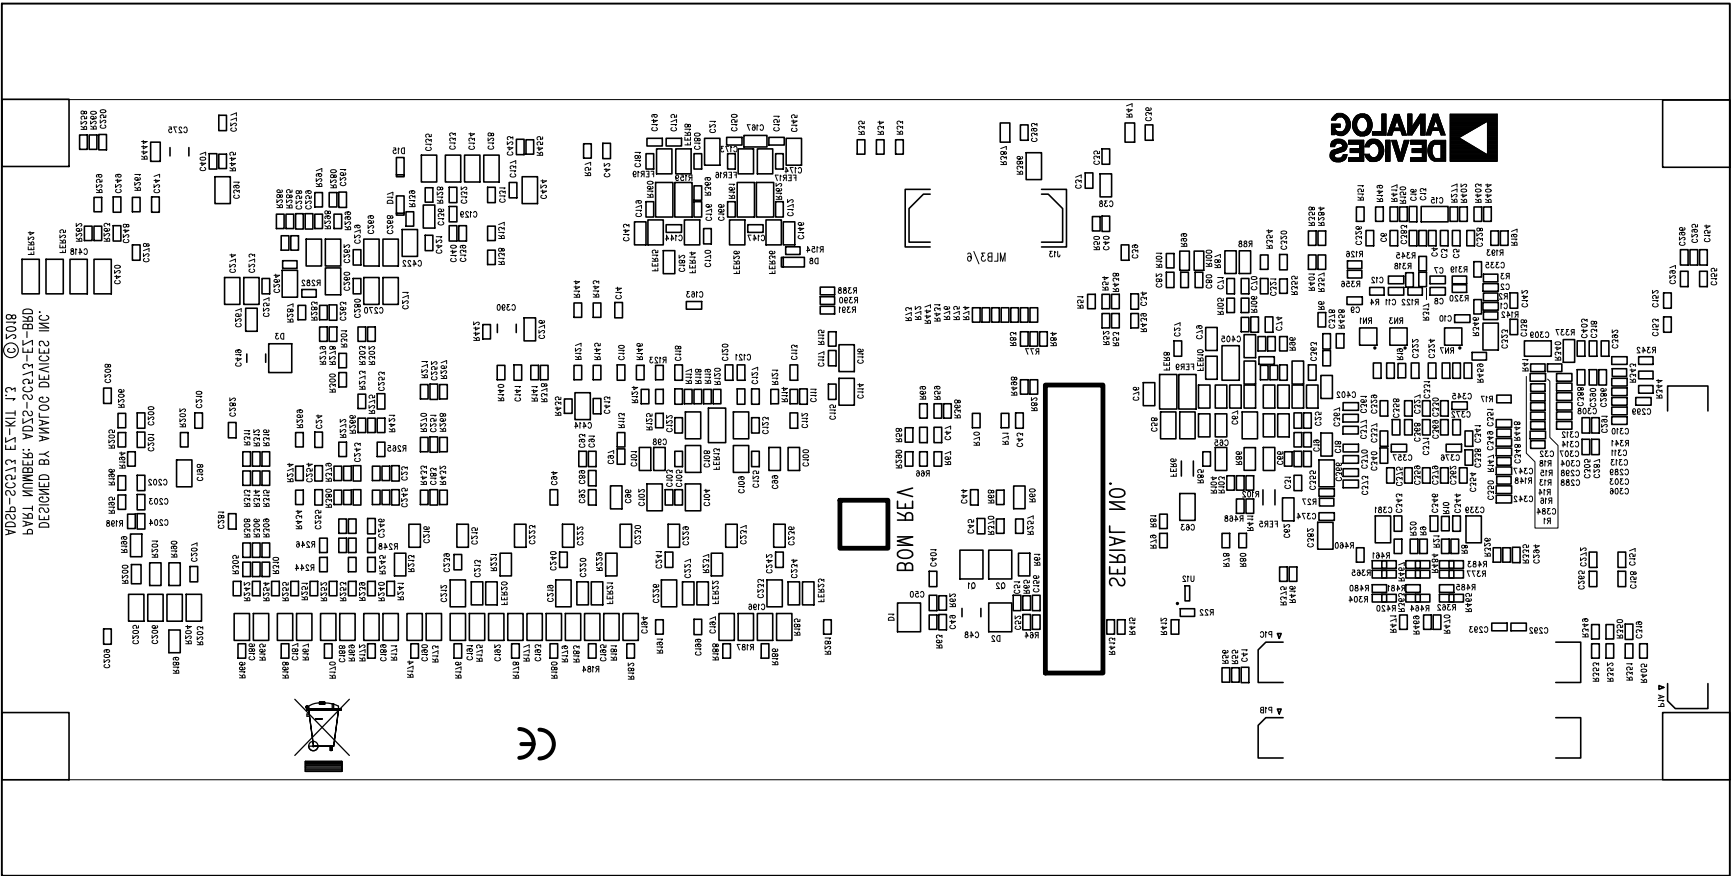


UNLESS OTHERWISE SPECIFIED DIMENSIONS ARE IN INCHES TOLERANCES ARE : .XX +/- .010 .XXX +/- .005	CONTRACT NO.		 2 Elizabeth Drive Chelmsford, MA 01824				
	APPROVALS	DATE					
MATERIAL	DRAWN	C.C.D.	05/15/18	SILKSCREEN BOTTOM SIDE ADSP-SC573 EZ-KIT			
	CHECKED						
FINISH	ENGINEERING			SIZE B	DWG. NO.	A0760-2015	REV. 1.3
	QUALITY						
DO NOT SCALE THIS DRAWING	MANUFACTURING			SCALE	1 : 1		SHEET 14 OF 16


REVISIONS				
REV	DESCRIPTION OF CHANGE	DRFTR	DATE	APPROVED
0.1	NEW RELEASE	C.C.D.	10/19/15	
0.2	UPDATED PER ECO2016-003	C.C.D.	02/02/16	
1.0	UPDATED PER ECO2016-016	C.C.D.	05/10/16	
1.1	UPDATED PER ECO2017-011	C.C.D.	03/02/17	
1.2	UPDATED PER ECO2017-0xx	C.C.D.	04/18/17	
1.2	UPDATED PER ECO2017-018	C.C.D.	10/13/17	
1.3	UPDATED PER ECO2018-006	C.C.D.	05/15/18	

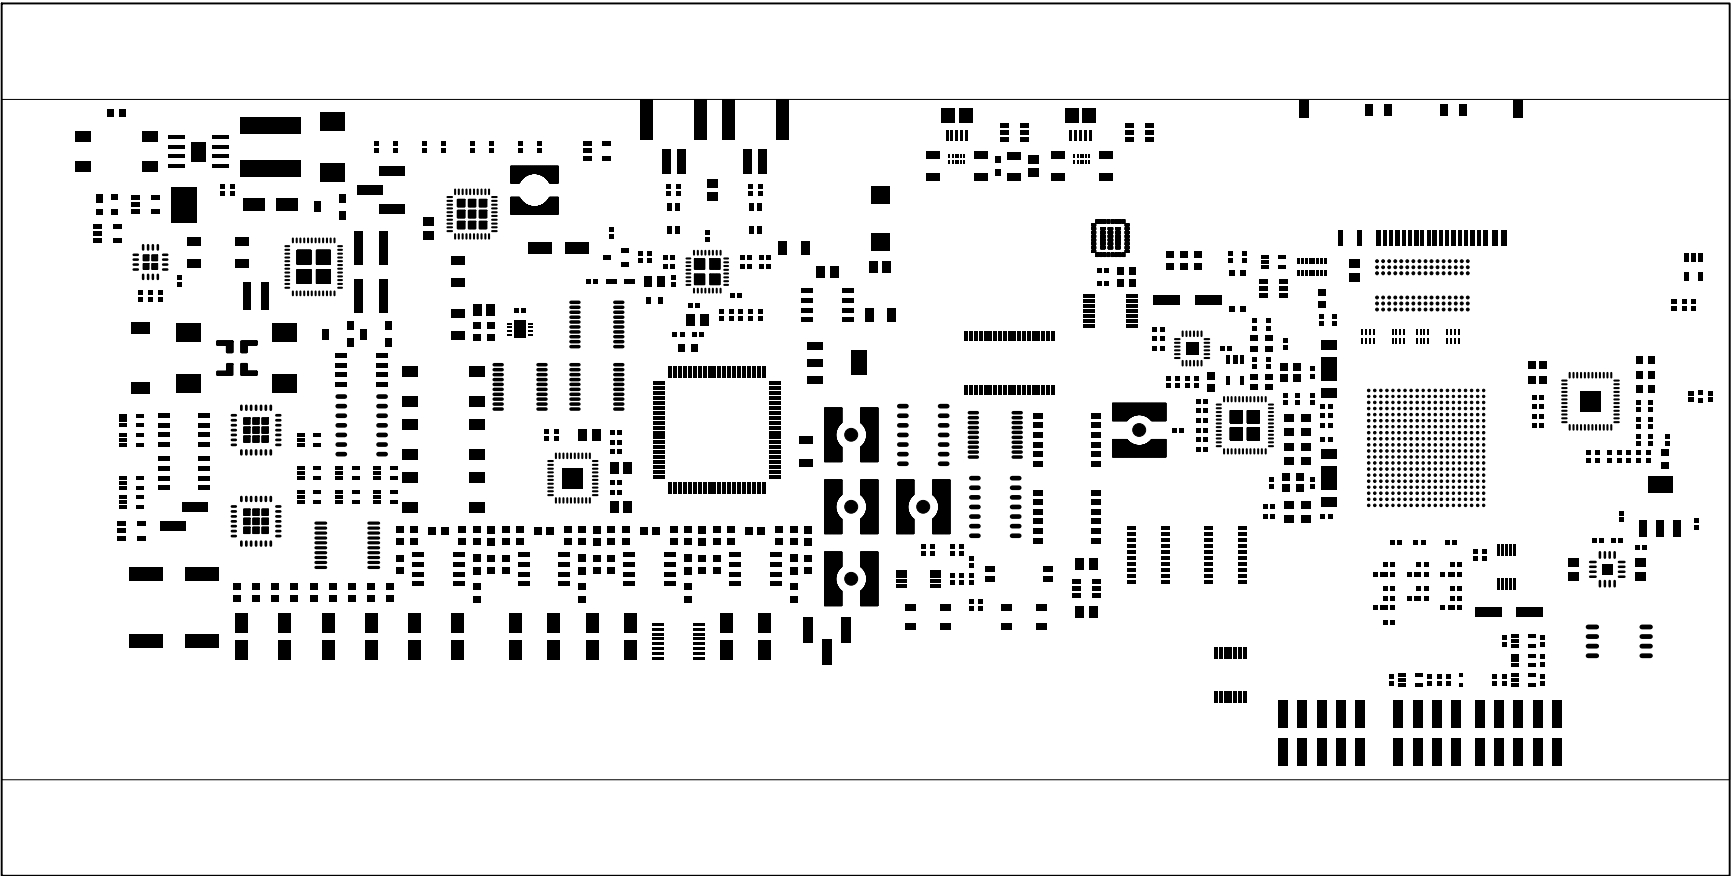

UNLESS OTHERWISE SPECIFIED DIMENSIONS ARE IN INCHES TOLERANCES ARE : .XX +/- .010 .XXX +/- .005	CONTRACT NO.		<div> 2 Elizabeth Drive Chelmsford, MA 01824</div>			
	APPROVALS	DATE				
	MATERIAL	DRAWN C.C.D.	05/15/18	SOLDER PASTE TOP SIDE ADSP-SC573 EZ-KIT		
	CHECKED					
FINISH	ENGINEERING		SIZE B	DWG. NO.	A0760-2015	REV. 1.3
	QUALITY					
DO NOT SCALE THIS DRAWING	MANUFACTURING		SCALE 1 : 1		SHEET 15 OF 16	

REVISIONS				
REV	DESCRIPTION OF CHANGE	DRFTR	DATE	APPROVED
0.1	NEW RELEASE	C.C.D.	10/19/15	
0.2	UPDATED PER EC02016-003	C.C.D.	02/02/16	
1.0	UPDATED PER EC02016-016	C.C.D.	05/10/16	
1.1	UPDATED PER EC02017-011	C.C.D.	03/02/17	
1.2	UPDATED PER EC02017-0xx	C.C.D.	04/18/17	
1.2	UPDATED PER EC02017-018	C.C.D.	10/13/17	
1.3	UPDATED PER EC02018-006	C.C.D.	05/15/18	

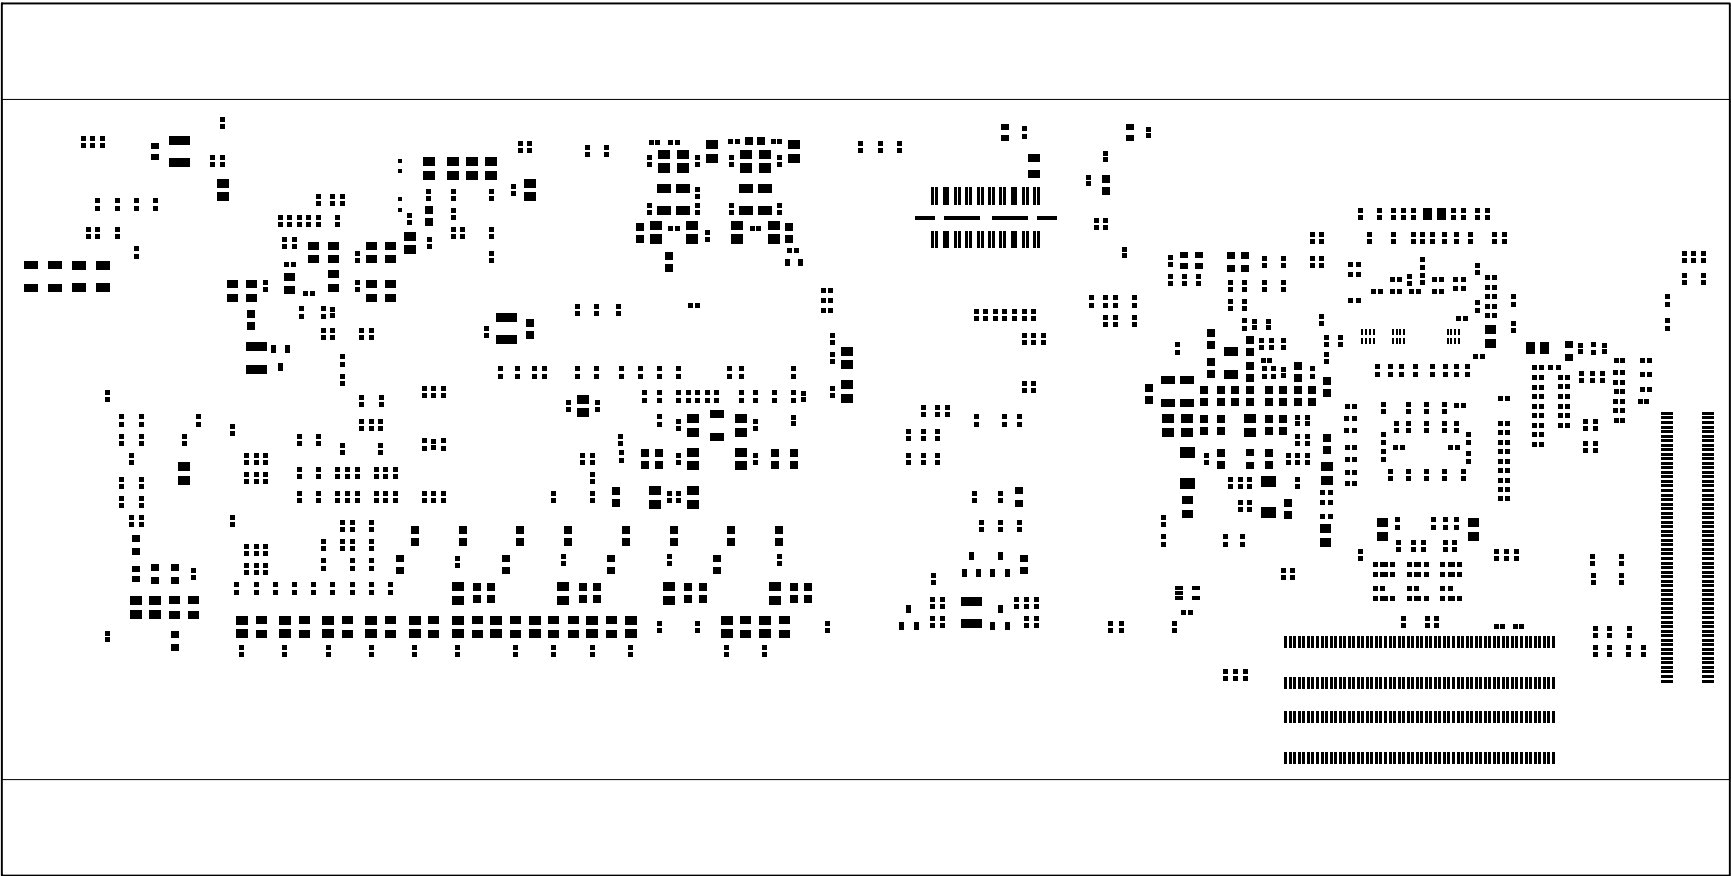

UNLESS OTHERWISE SPECIFIED DIMENSIONS ARE IN INCHES TOLERANCES ARE : .XX +/- .010 .XXX +/- .005	CONTRACT NO.		<div><div></div><div>2 Elizabeth Drive Chelmsford, MA 01824</div></div>			
	APPROVALS	DATE				
	MATERIAL	DRAWN C.C.D.	05/15/18	SOLDER PASTE BOTTOM SIDE ADSP-SC573 EZ-KIT		
	CHECKED					
FINISH	ENGINEERING		SIZE B	DWG. NO.	A0760-2015	REV. 1.3
	QUALITY					
DO NOT SCALE THIS DRAWING	MANUFACTURING		SCALE 1 : 1	SHEET 16 OF 16		